





MENENDEZ &
ASSOCIATES
ARCHITECTS
PLANNERS INC.
WEST PALM BEACH
FLORIDA, 33401
(305) 889-0714

SITE PLAN PHASE ONE

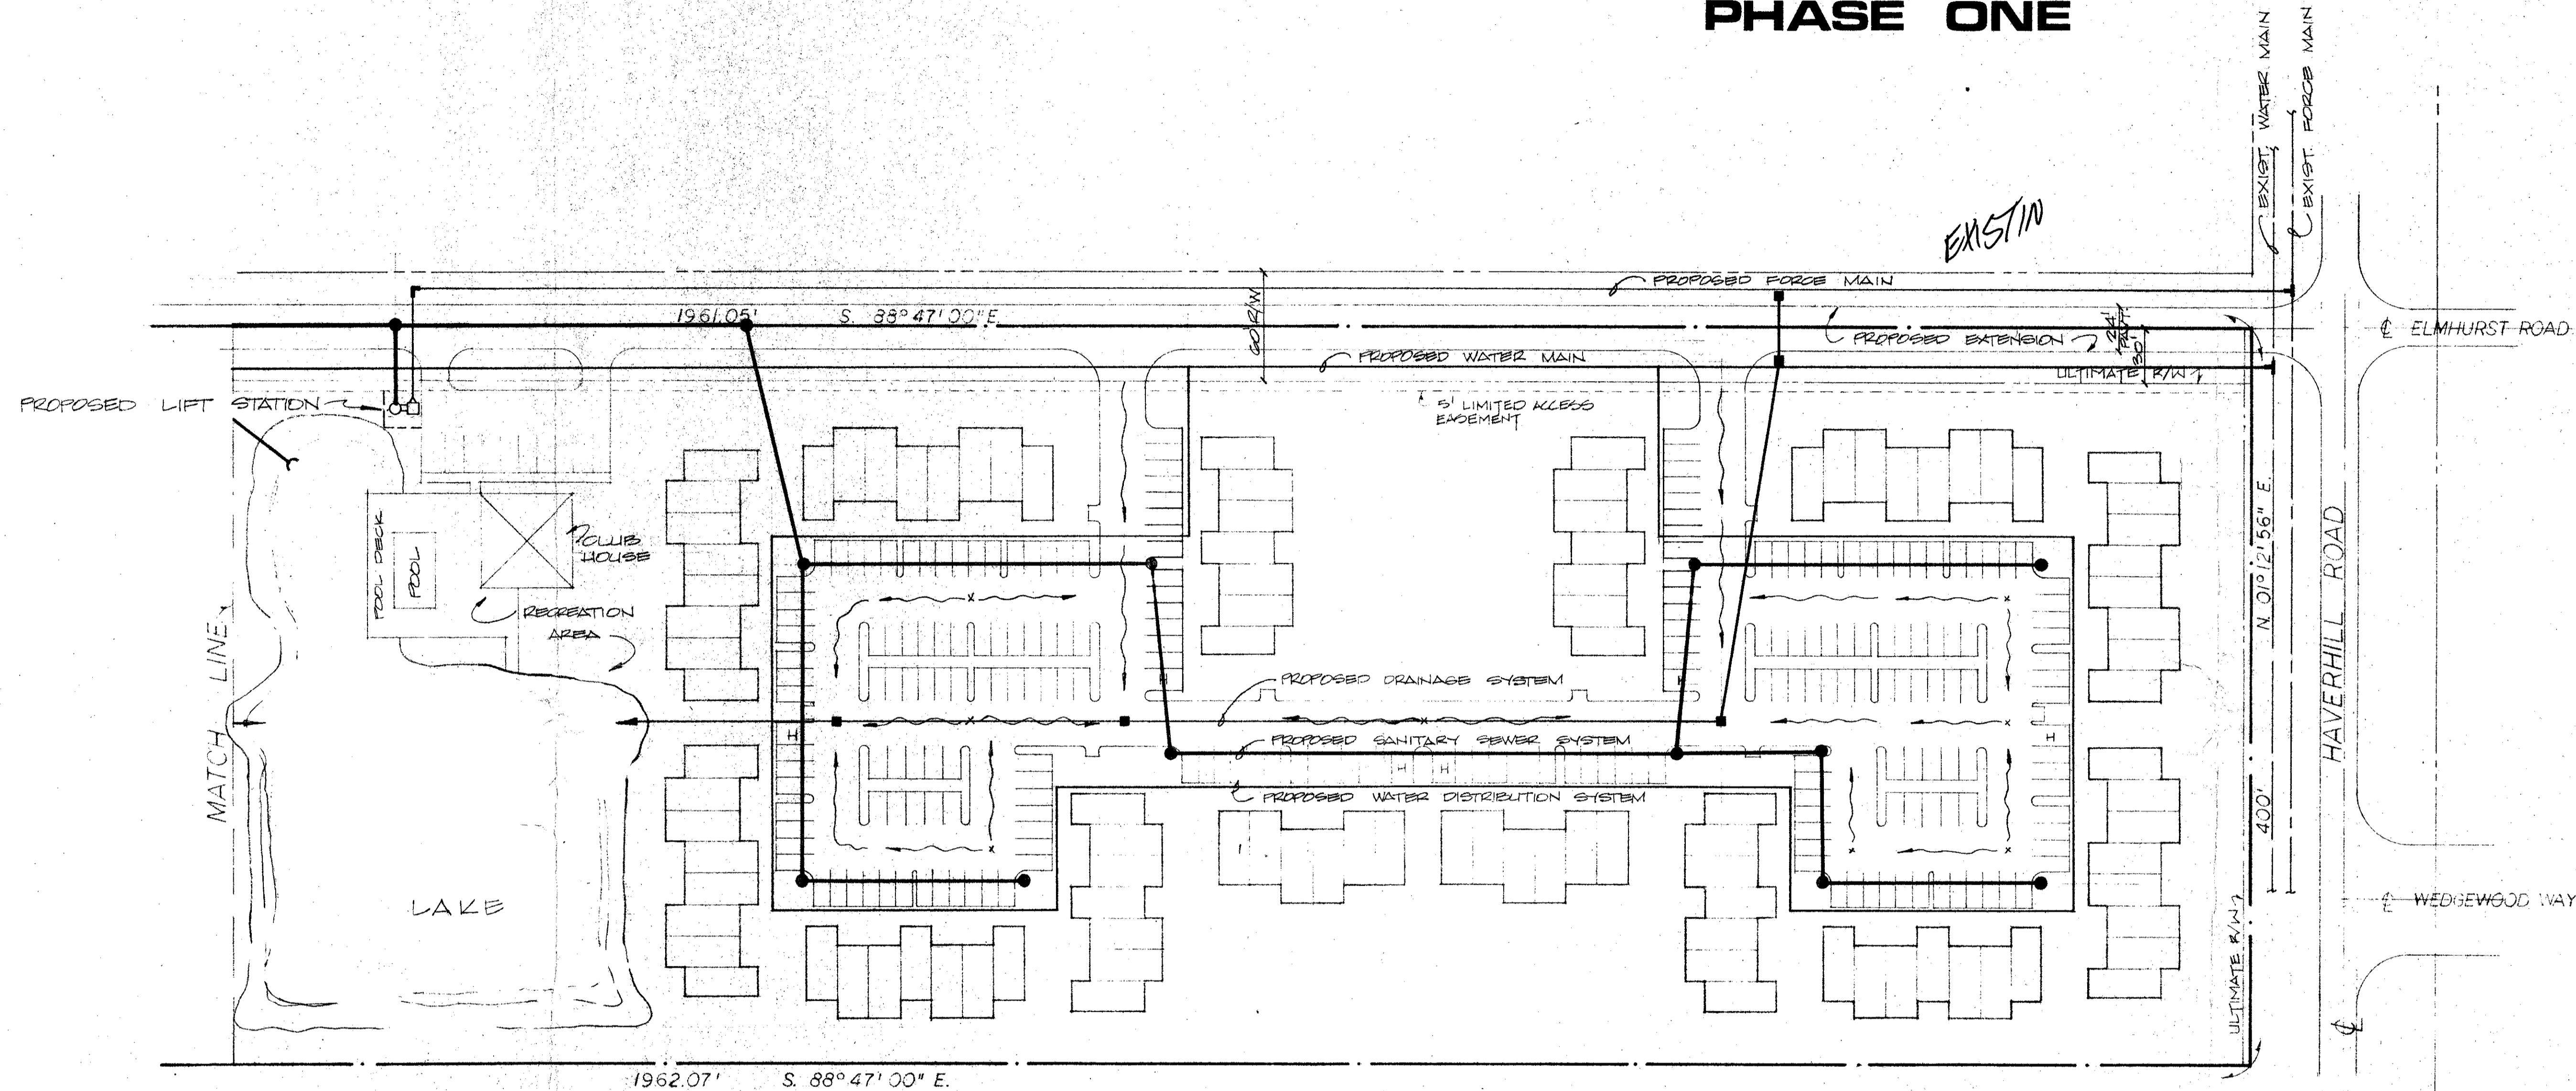

WATER, SEWER, DRAINAGE

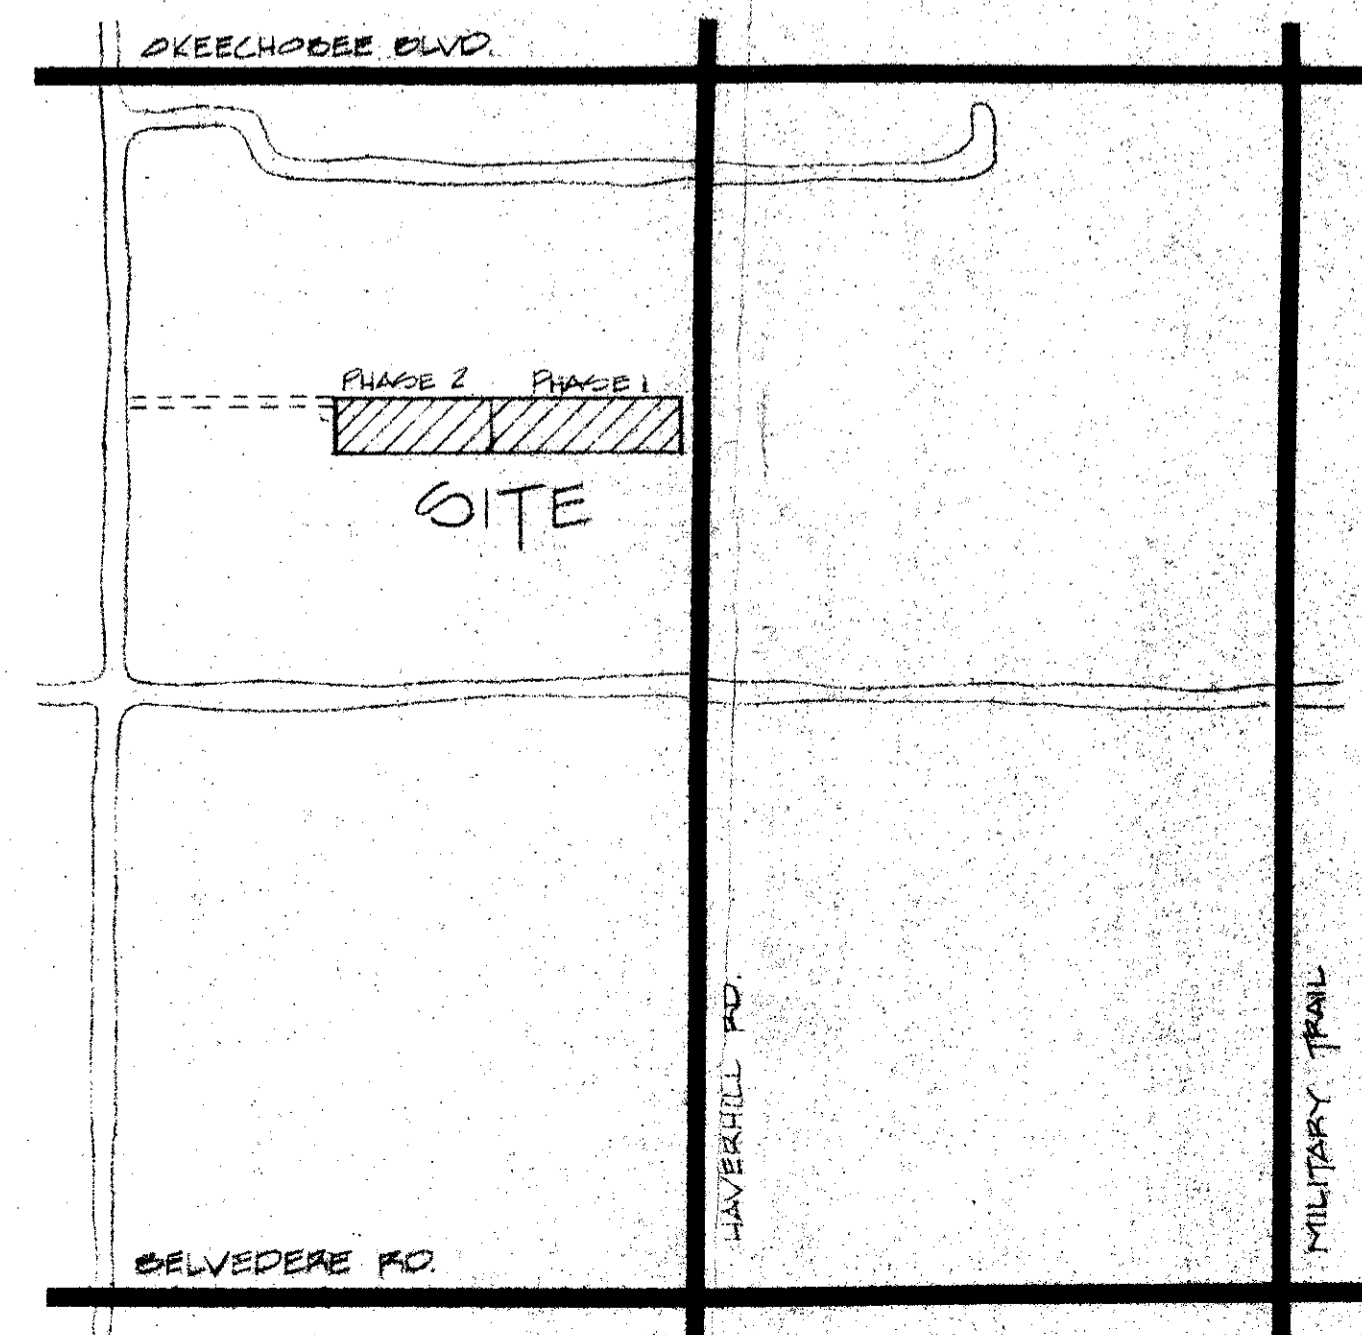

LOCATION

THE COMMONS
PALM BEACH COUNTY, FLA.

PREPARED FOR: JAN A. WOLFE AS TRUSTEE, W. PALM BEACH, FLA.

79011

DRAWN BY	DATE
	7-17-10
REVISIONS	DATE
SCALE: 1" = 50'	

ur0276.igr
THE COMMONS DRAINAGE 1 OF 2

1 OF 2

