


**MENENDEZ & ASSOCIATES ARCHITECTS PLANNERS INC.**  
 WEST PALM BEACH, FLORIDA, 33401  
 (305) 888-0714

# SITE PLAN PHASE TWO

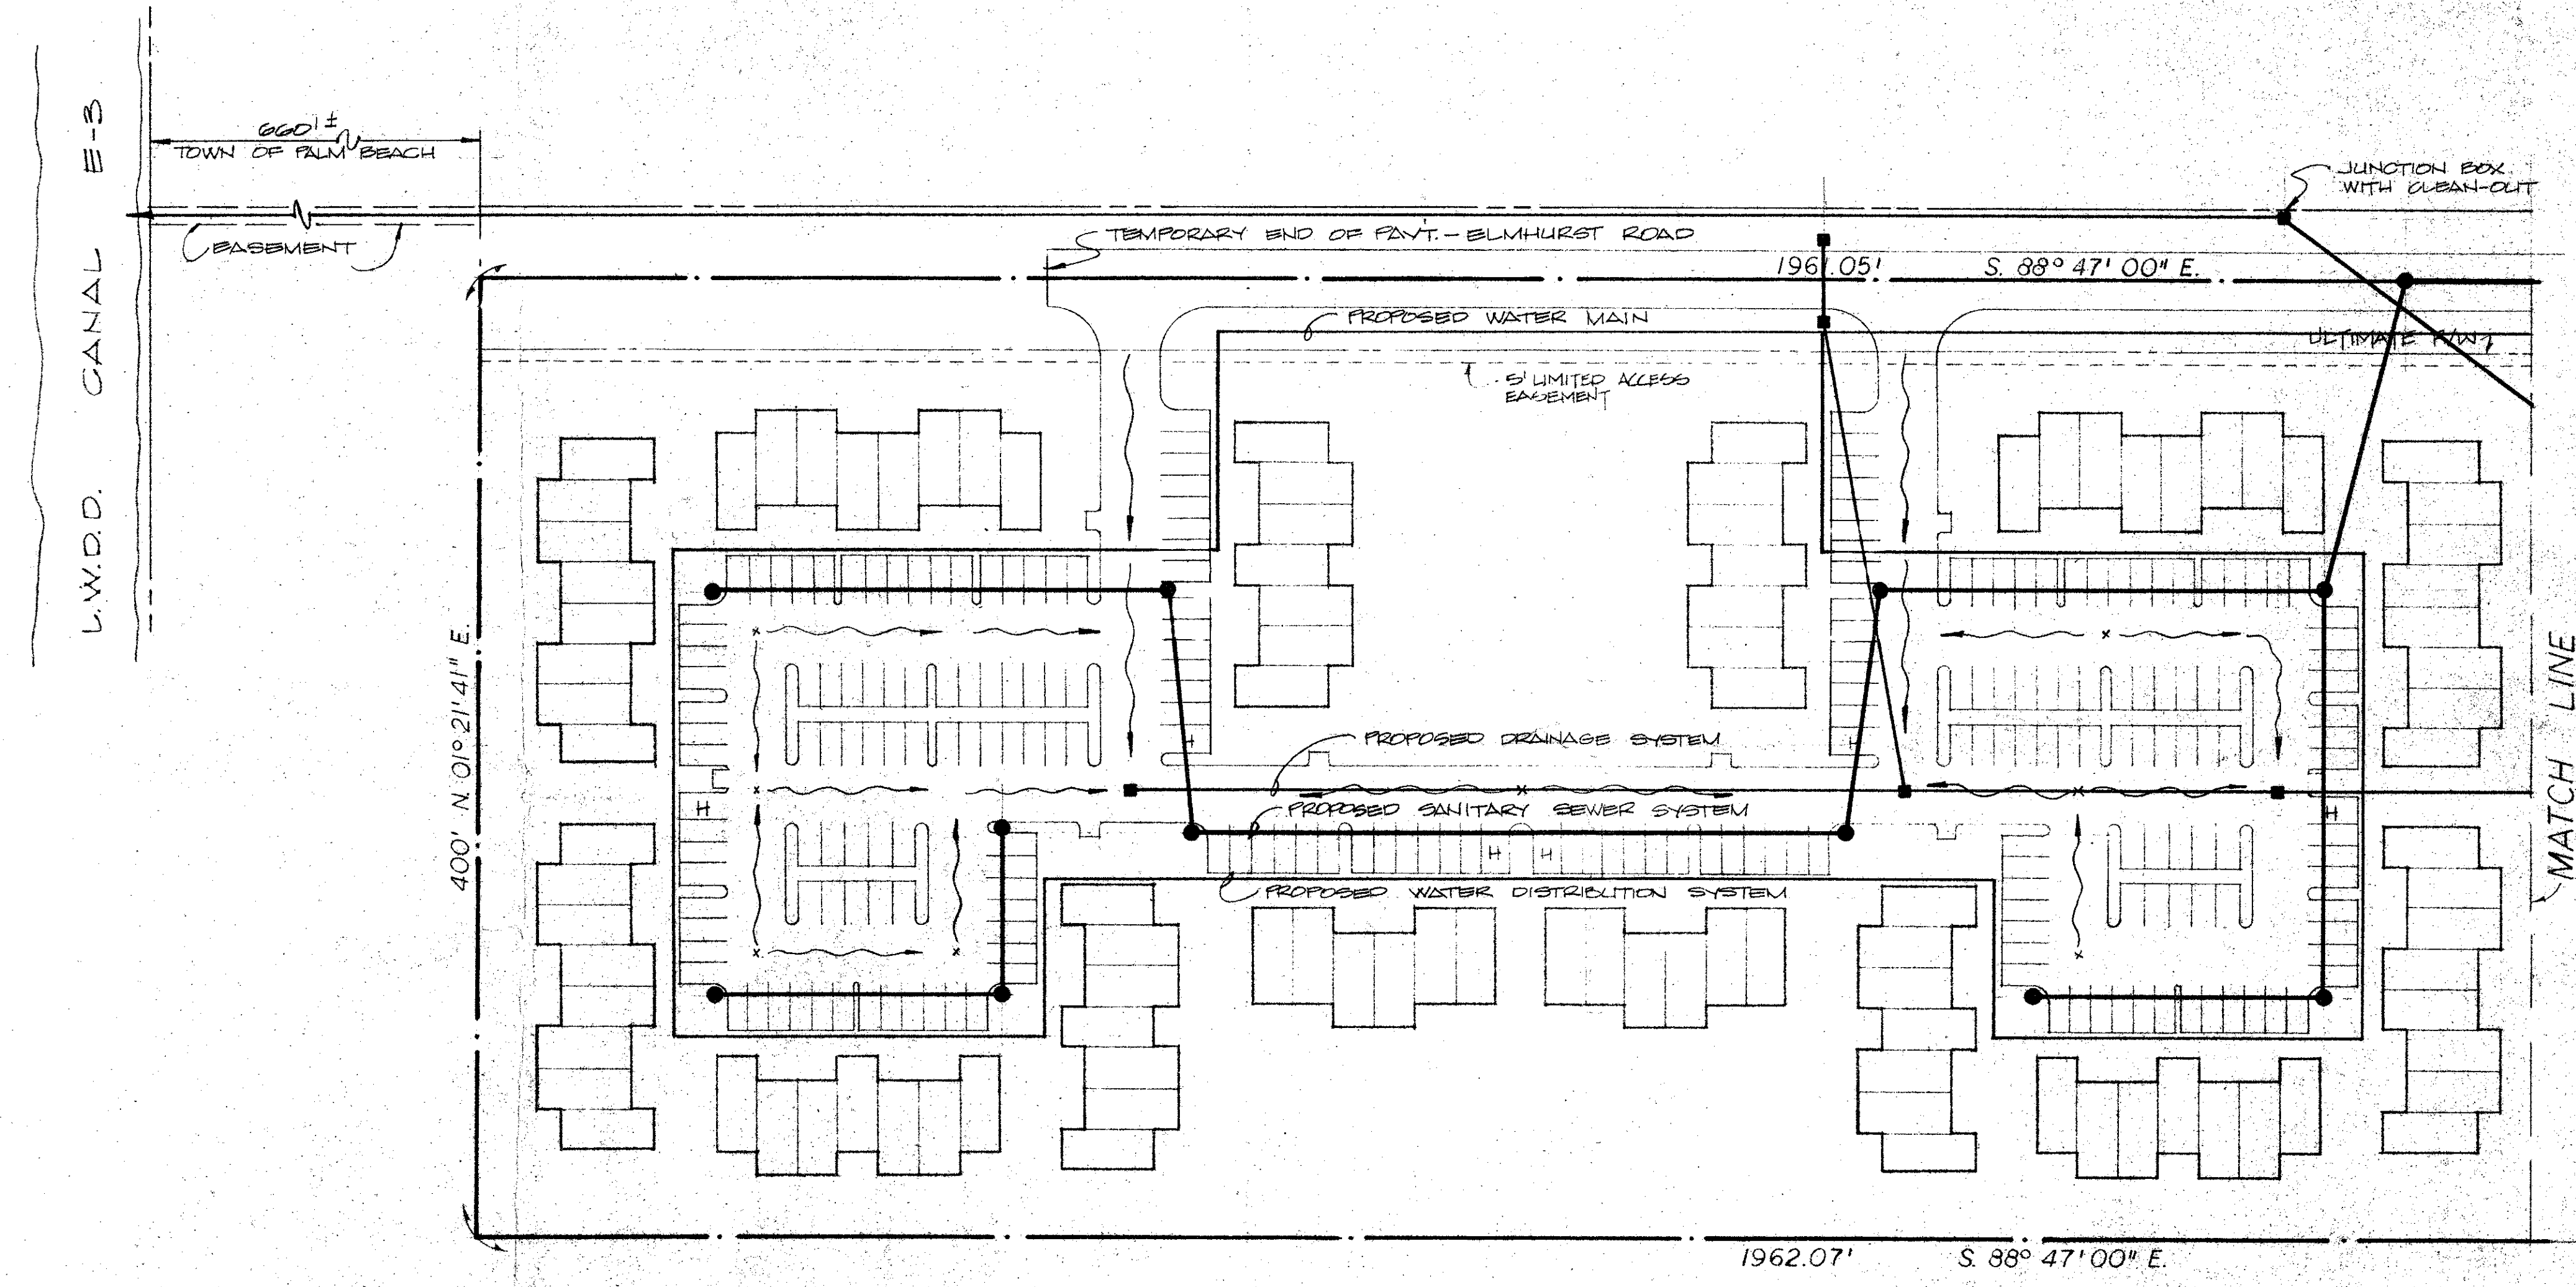

## WATER, SEWER, DRAINAGE

**THE COMMONS**  
 PALM BEACH COUNTY, FLA.  
 PREPARED FOR: JAN A. WOLFE AS TRUSTEE, W. PALM BEACH, FLA.

79011

DRAWN BY	DATE
REVISIONS	DATE
SCALE: 1" = 50'	

2 OF 2



ur0277.igr  
 THE COMMONS DRAINAGE 2 OF 2

BRUNING 4021 29042